
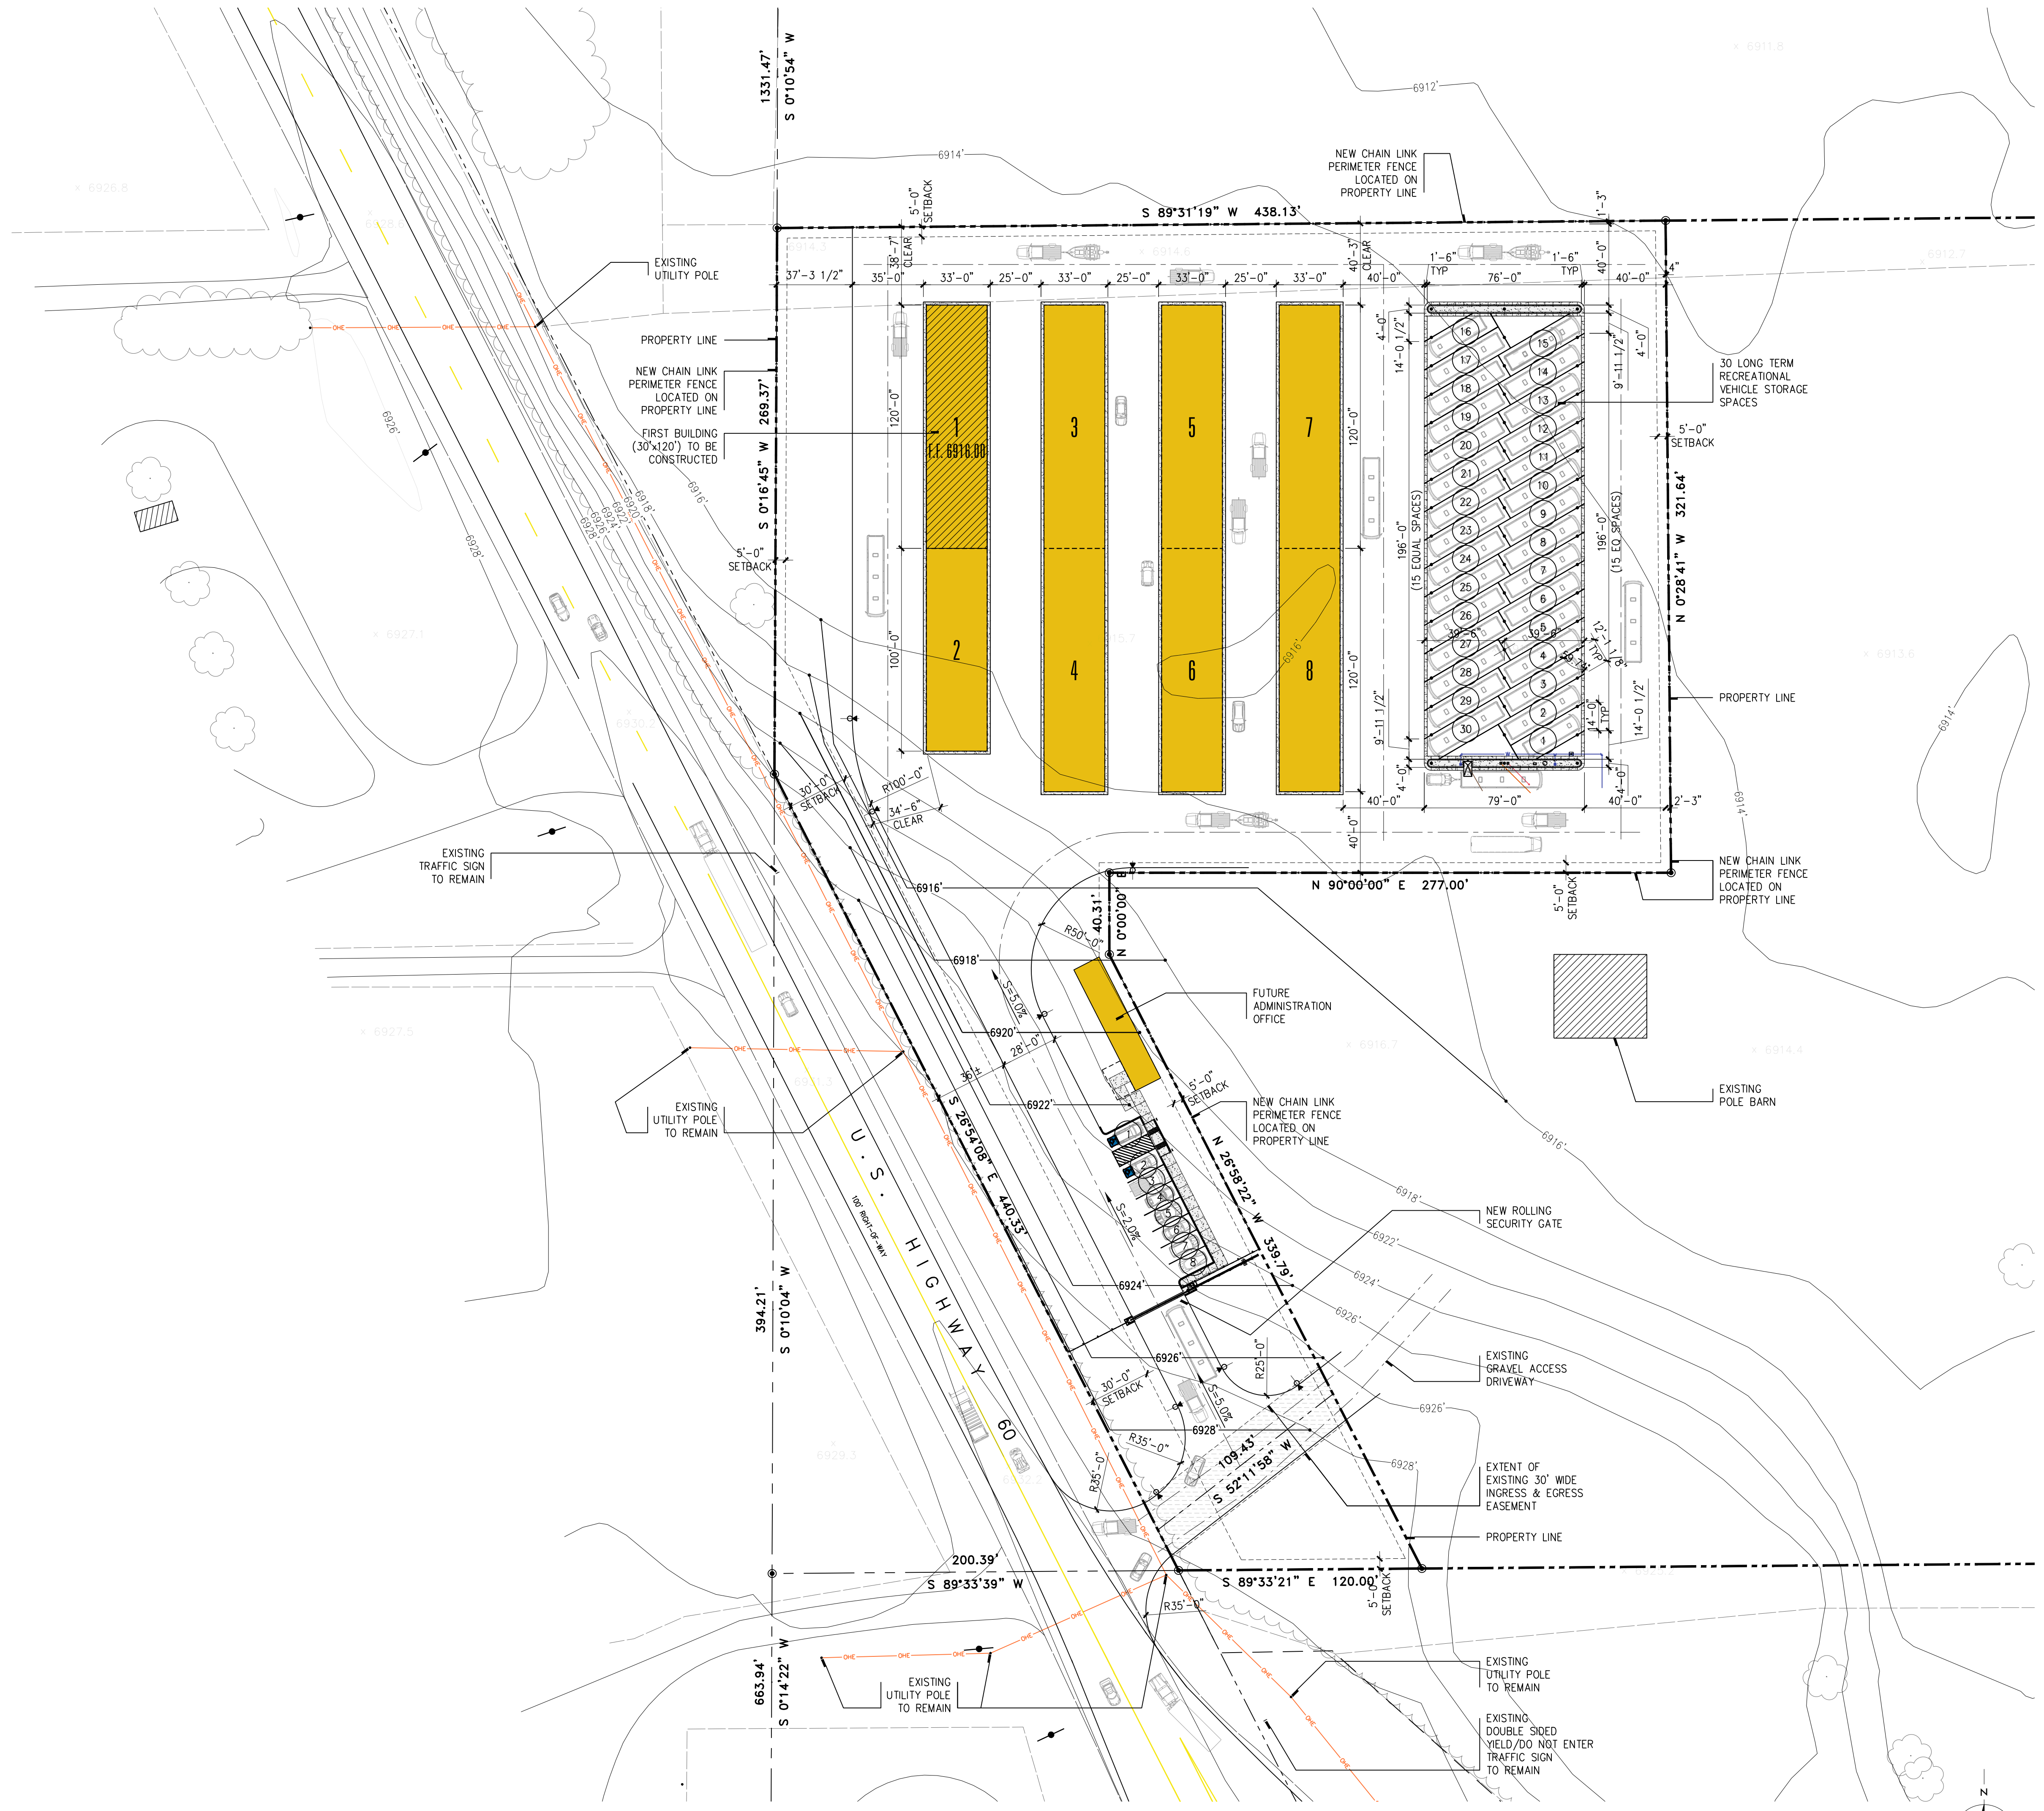



P:\2022\210 Active Documents\Drawings\A001\A001.dwg, A001 (DWG), 3/1/2022 9:57:34 AM, 1:2022.dwg, DWG TO PDF, 03/01/2022 10:00:24 AM (Internal), 12/2

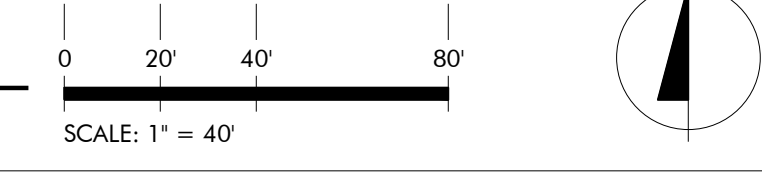

SITE PLAN

Weller Architects
 401 Alvarado Drive SE, Suite D Albuquerque, New Mexico 87108
 tel 505 255 8270 fax 505 255 8830

COPPEDGE STORAGE

Springerville Arizona

Weller Project No: 2022.01
 Drawn By: TEC
 Checked By: MDC
 Date: 03.31.2022